


LEGEND

DRAINAGE AREA
AREA SIZE (sq.m.)
5-YEAR RUNOFF COEFFICIENT

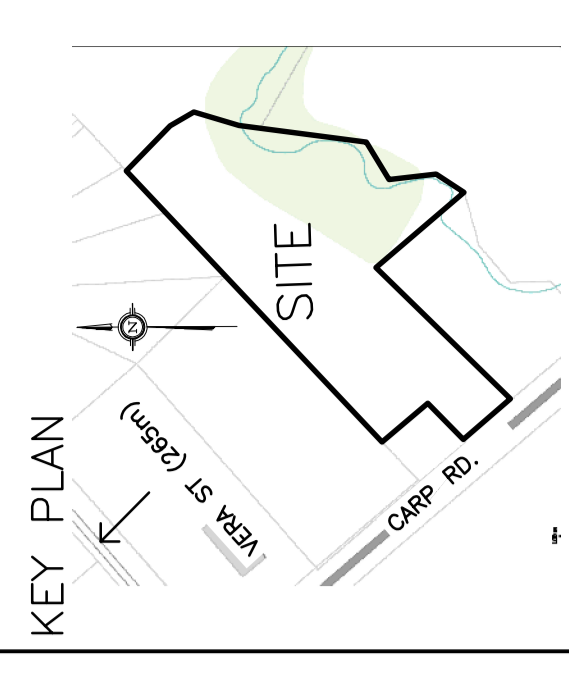

No.	Date	REVISION
2	MAR 19-18	RE-ISSUED FOR APPROVAL
1	JAN 16-18	RE-ISSUED FOR APPROVAL


D. B. GRAY ENGINEERING INC.
 700 Long Point Circle
 Ottawa, Ontario K1T 4E9
 Tel: 613-425-8044
 d.gray@dbgrayengineering.com

**PROPOSED
 2 STOREY GARAGE BUILDING**
 2688 CARP ROAD
 OTTAWA, ONTARIO

**DRAINAGE PLAN
 (INFILTRATION TRENCHES)**

Engineer's Seal

 Drawing No. **C-4** of **4**

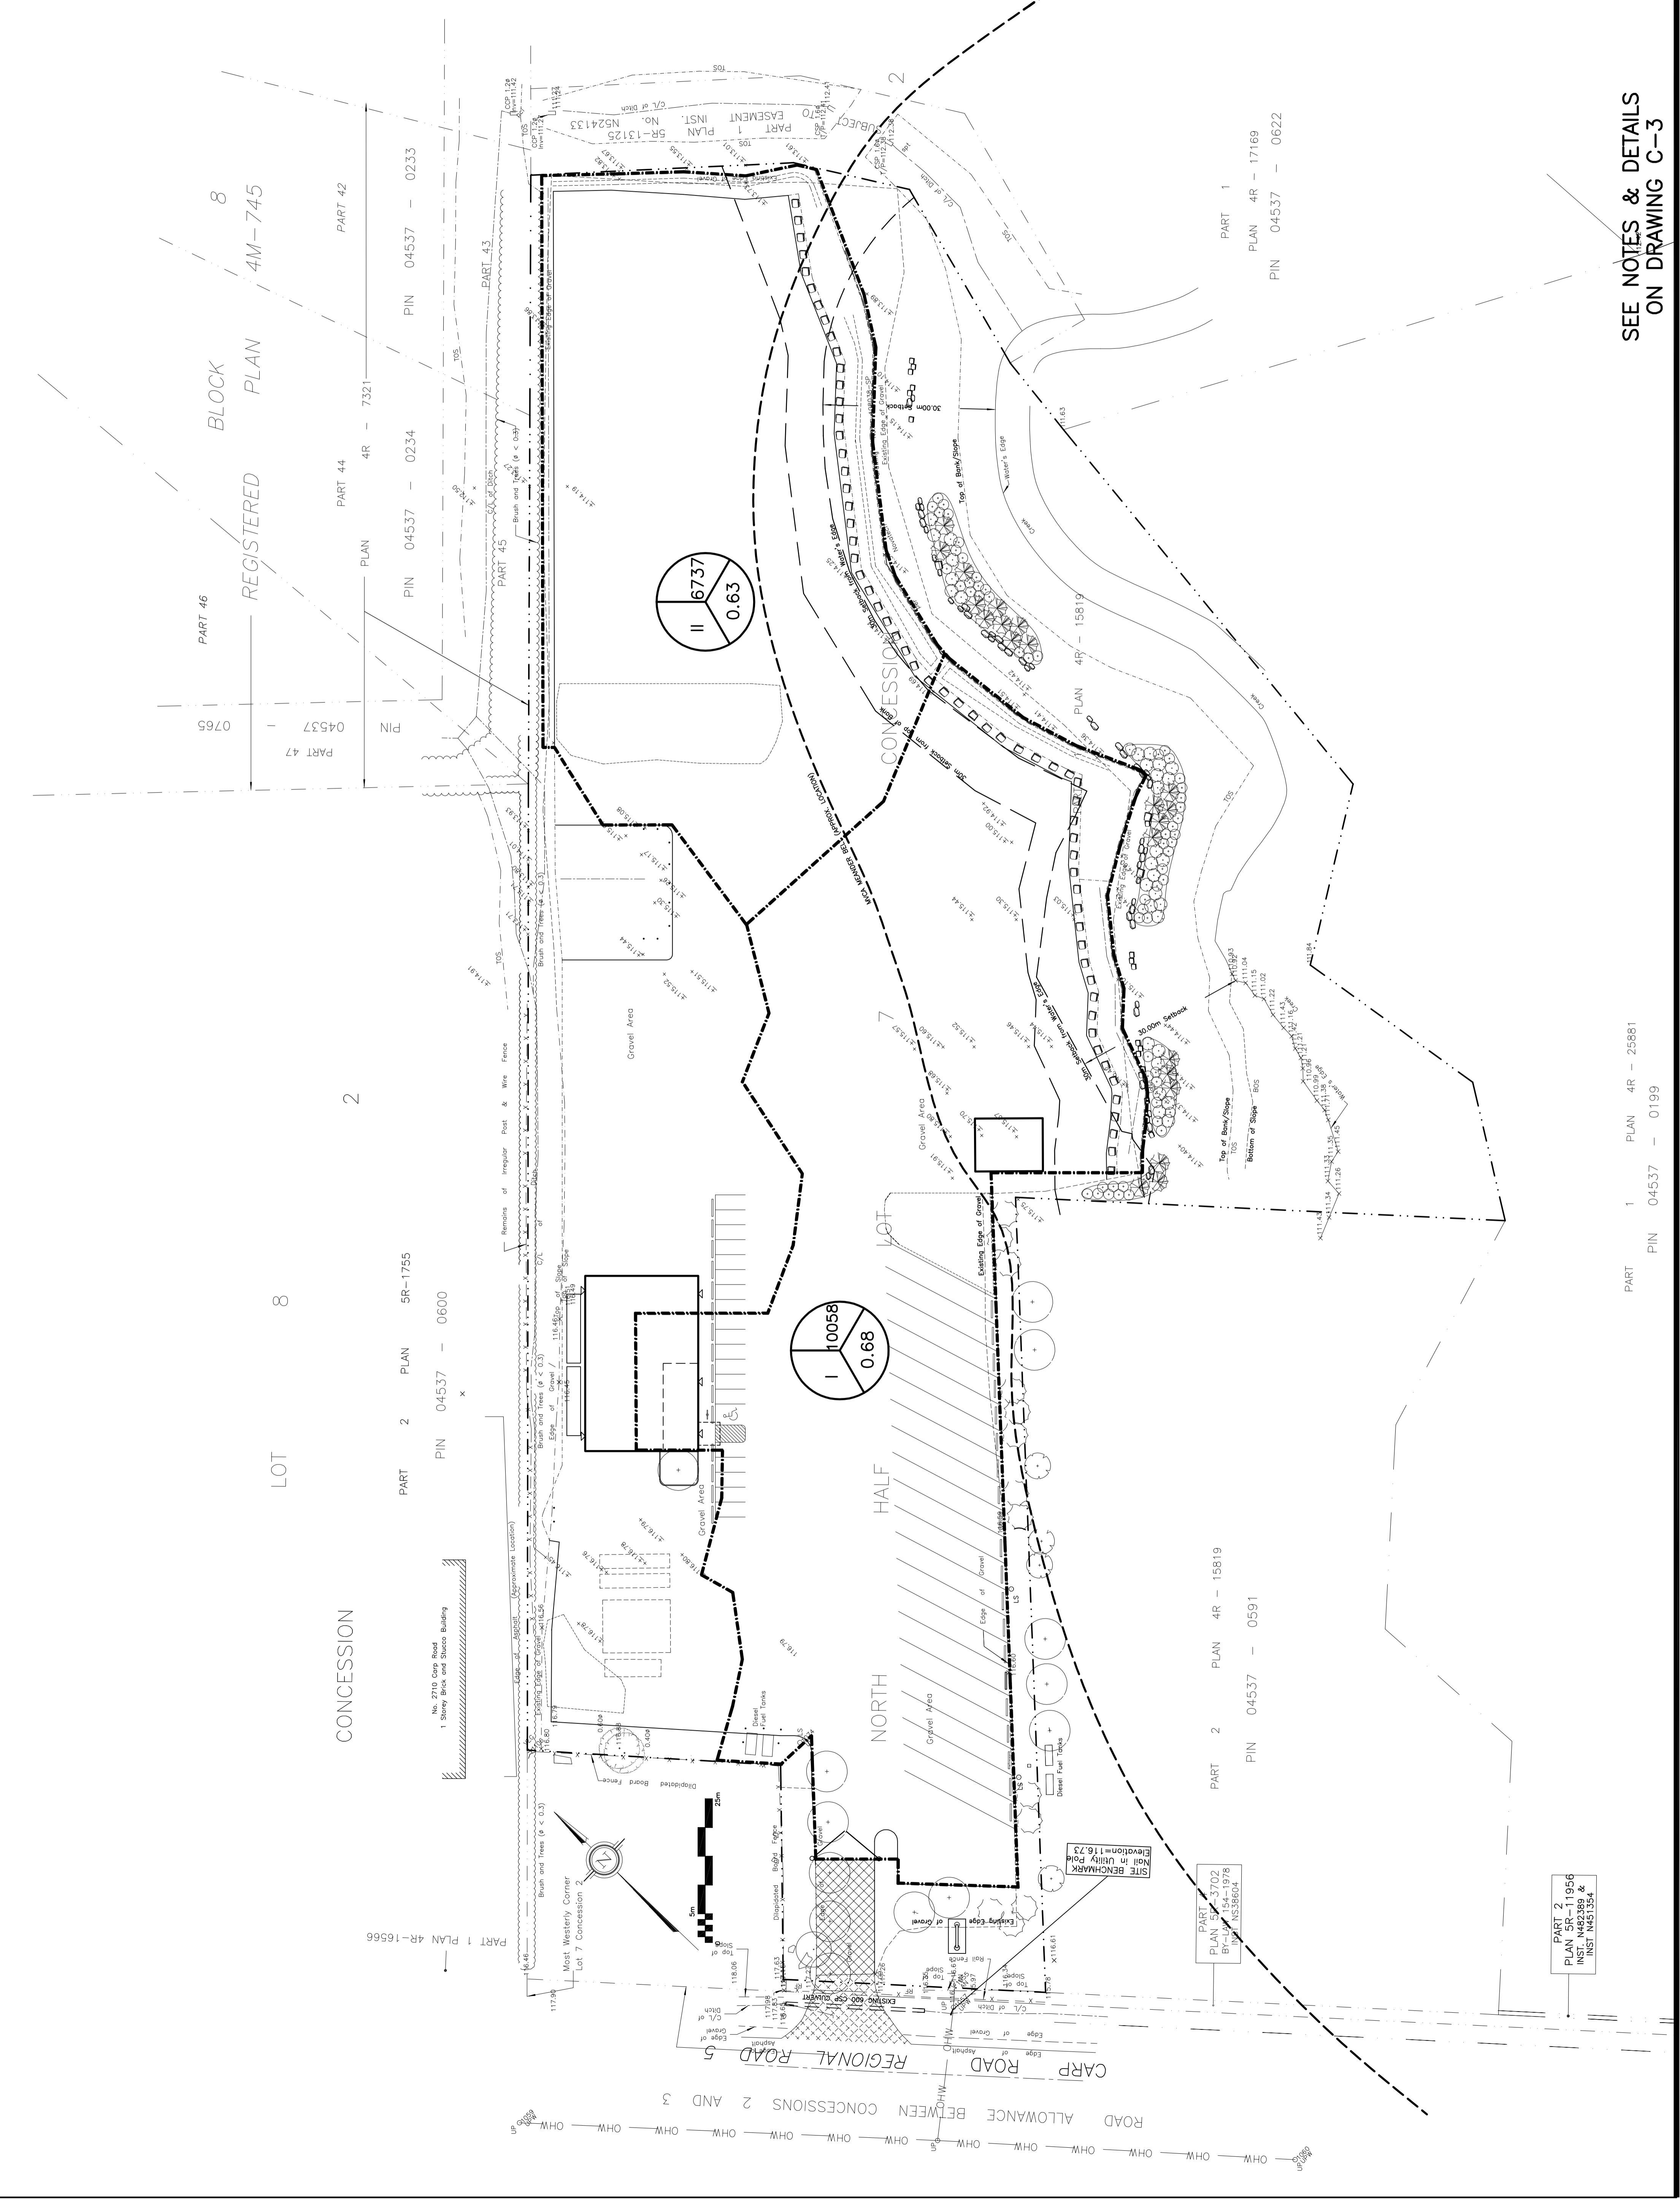

SEE NOTES & DETAILS
 ON DRAWING C-3

PART 1 PLAN 4R - 25881
 PIN 04537 - 0199

PART 2 PLAN 4R - 15819
 PIN 04537 - 0591

PART 2 PLAN 4R - 0956
 INST. N492389 &
 INST. N4451354