



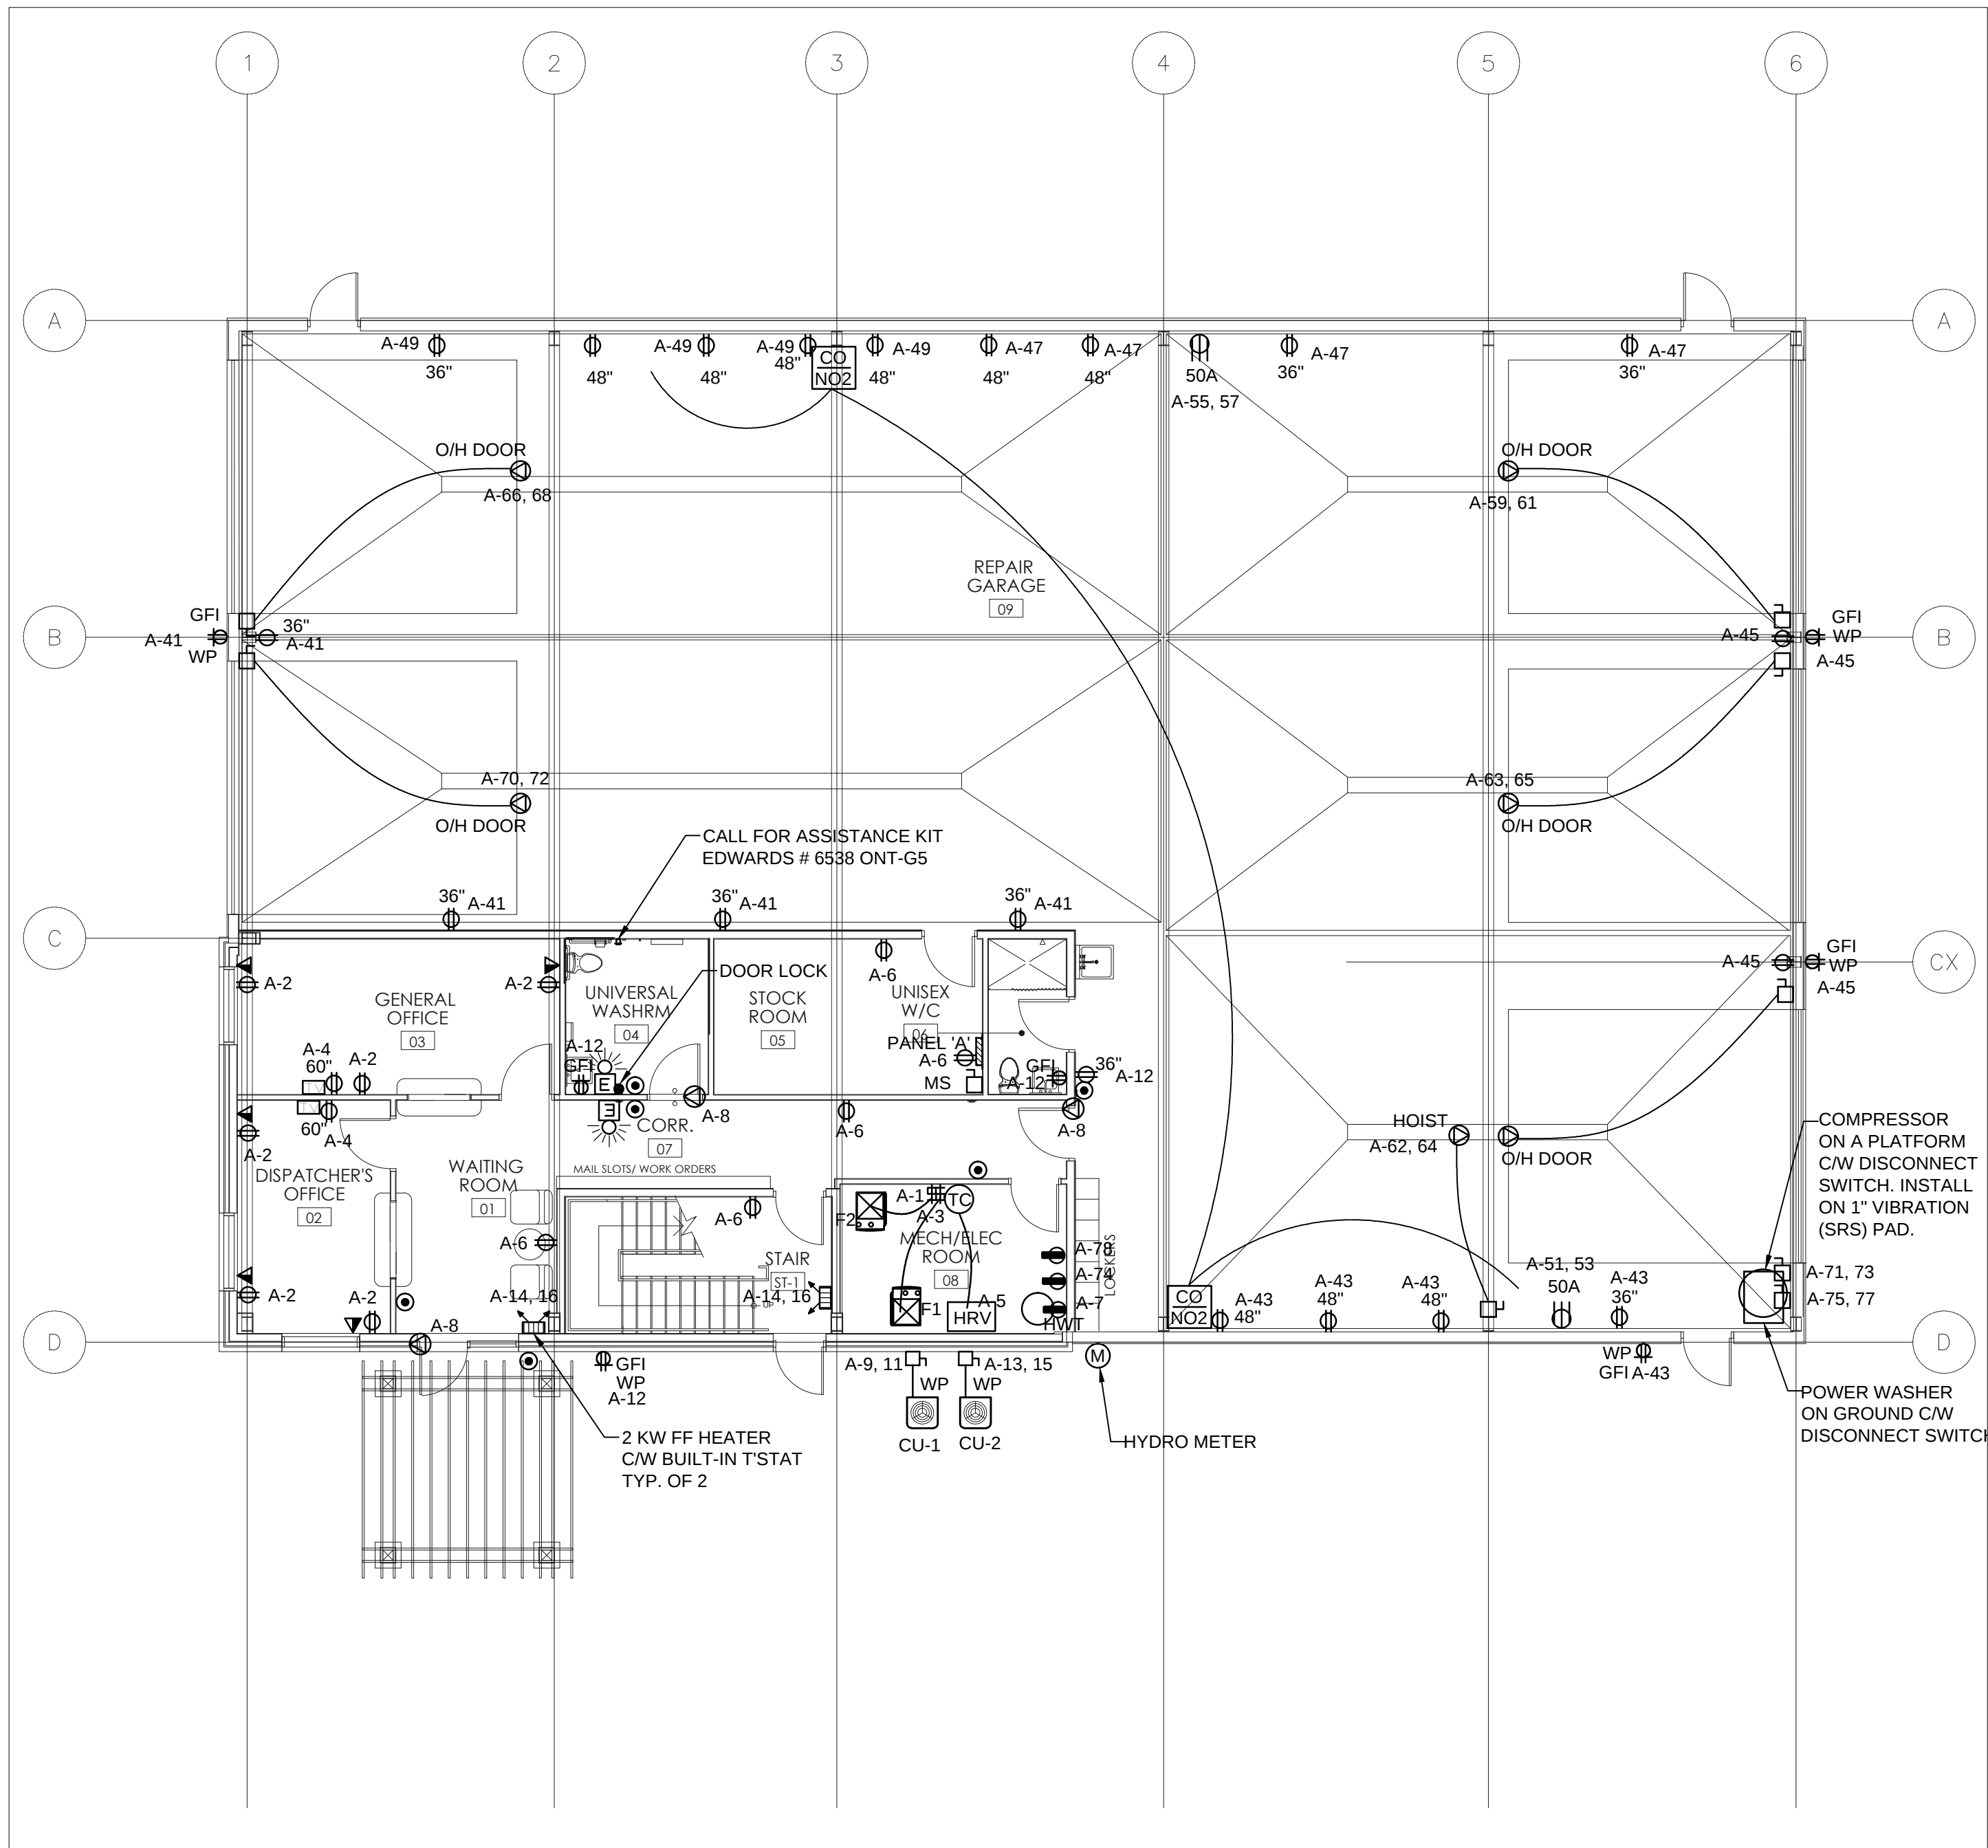

GROUND FLOOR

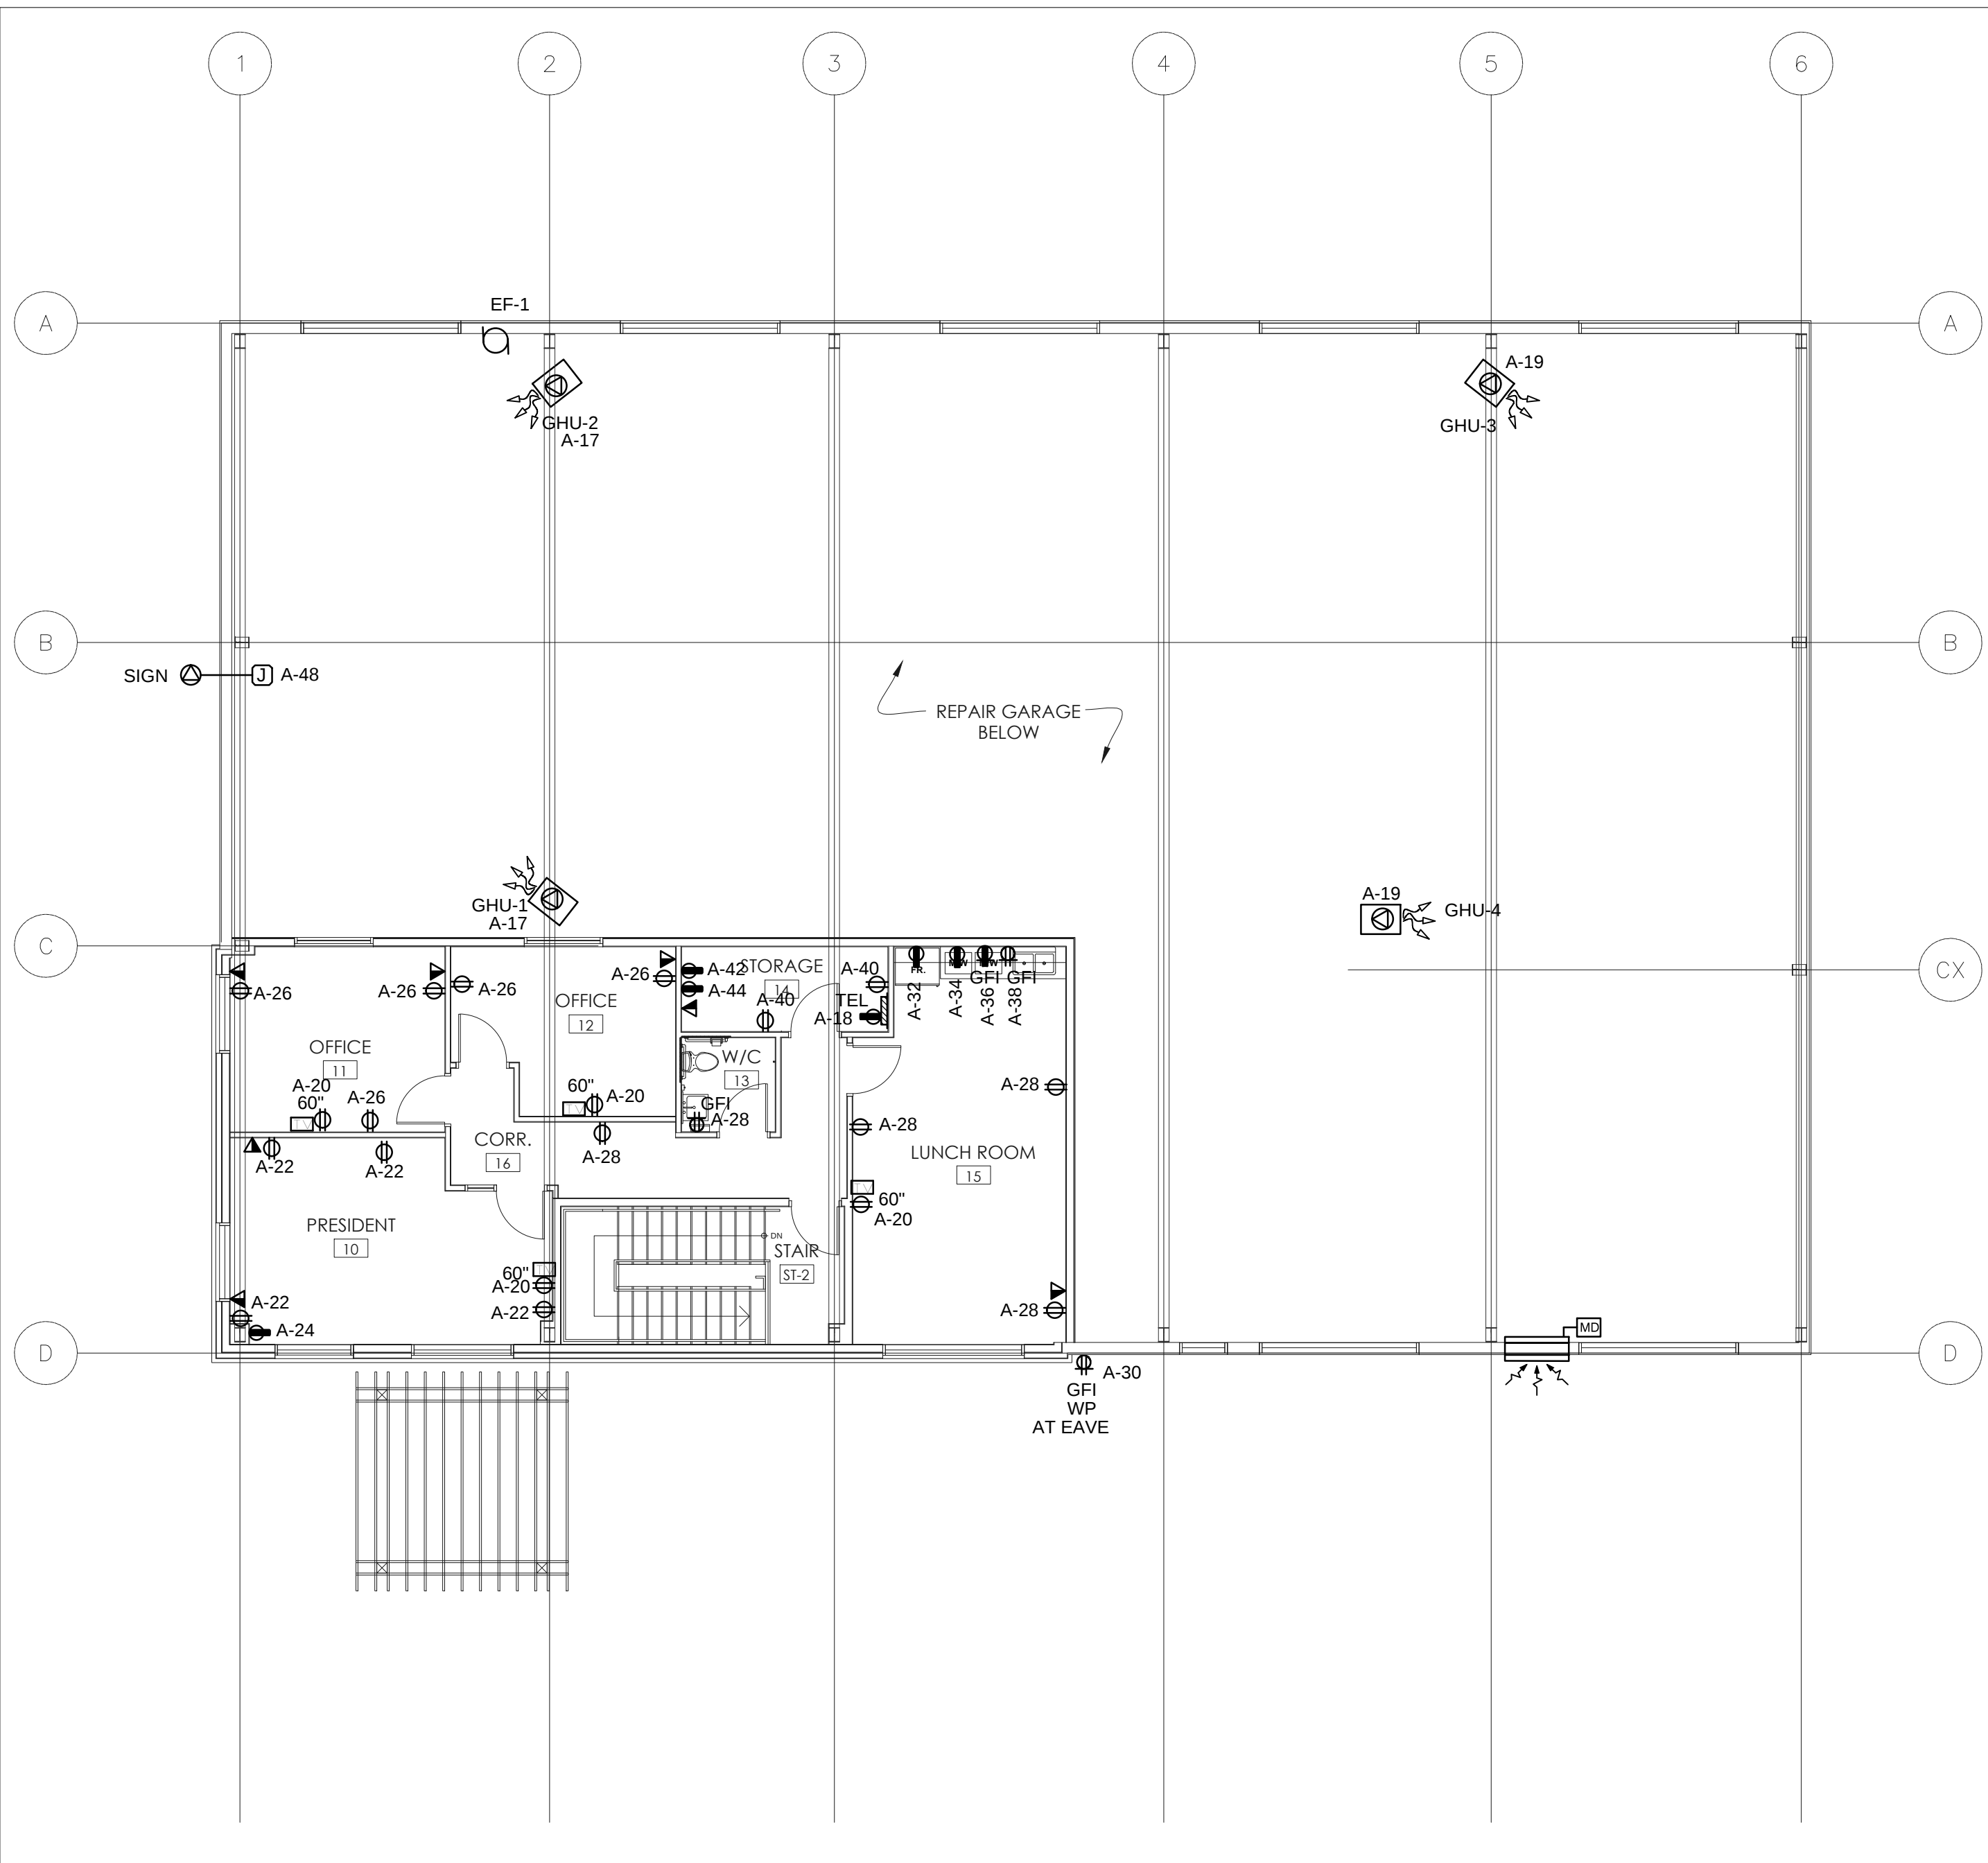


2nd FLOOR

NO.	DATE	REVISION	NAME
3	APR. 20, 2018	ADDED FIRE DAMPERS DELETED 4 TALL PIPE DUCTS REVISED EF-1	MY
2	FEB. 28, 2018	PRICING	MY
1	JAN. 24, 2018	BUILDING PERMIT	MY

205 Kincardine Drive, Kanata, Ontario, K2V1C5
Tel: 613-836-3420 Fax: 613-836-5957

THIS DRAWING IS THE SOLE PROPERTY OF
M & E ENGINEERING. REPRODUCTION
IS NOT PERMITTED

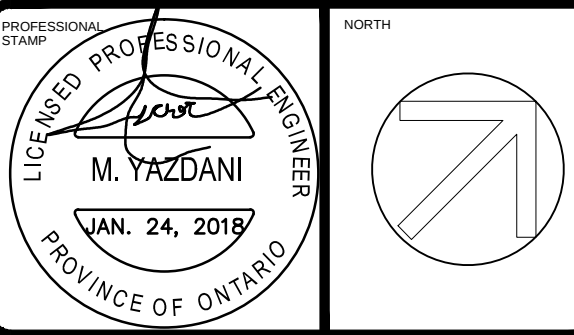

PROJECT
BRY-AIN HOLDINGS LTD.
EQUIPMENT REPAIR GARAGE
2688 CARP RD, OTTAWA, ON

DRAWING
GROUND & 2nd FLOOR
POWER LAYOUTS

PROJECT NUMBER

CHECKED BY MY DESIGNED BY MY

DRAWN BY SY SCALE 1 : 100

DATE DRAWING NUMBER

REVISION E-2