

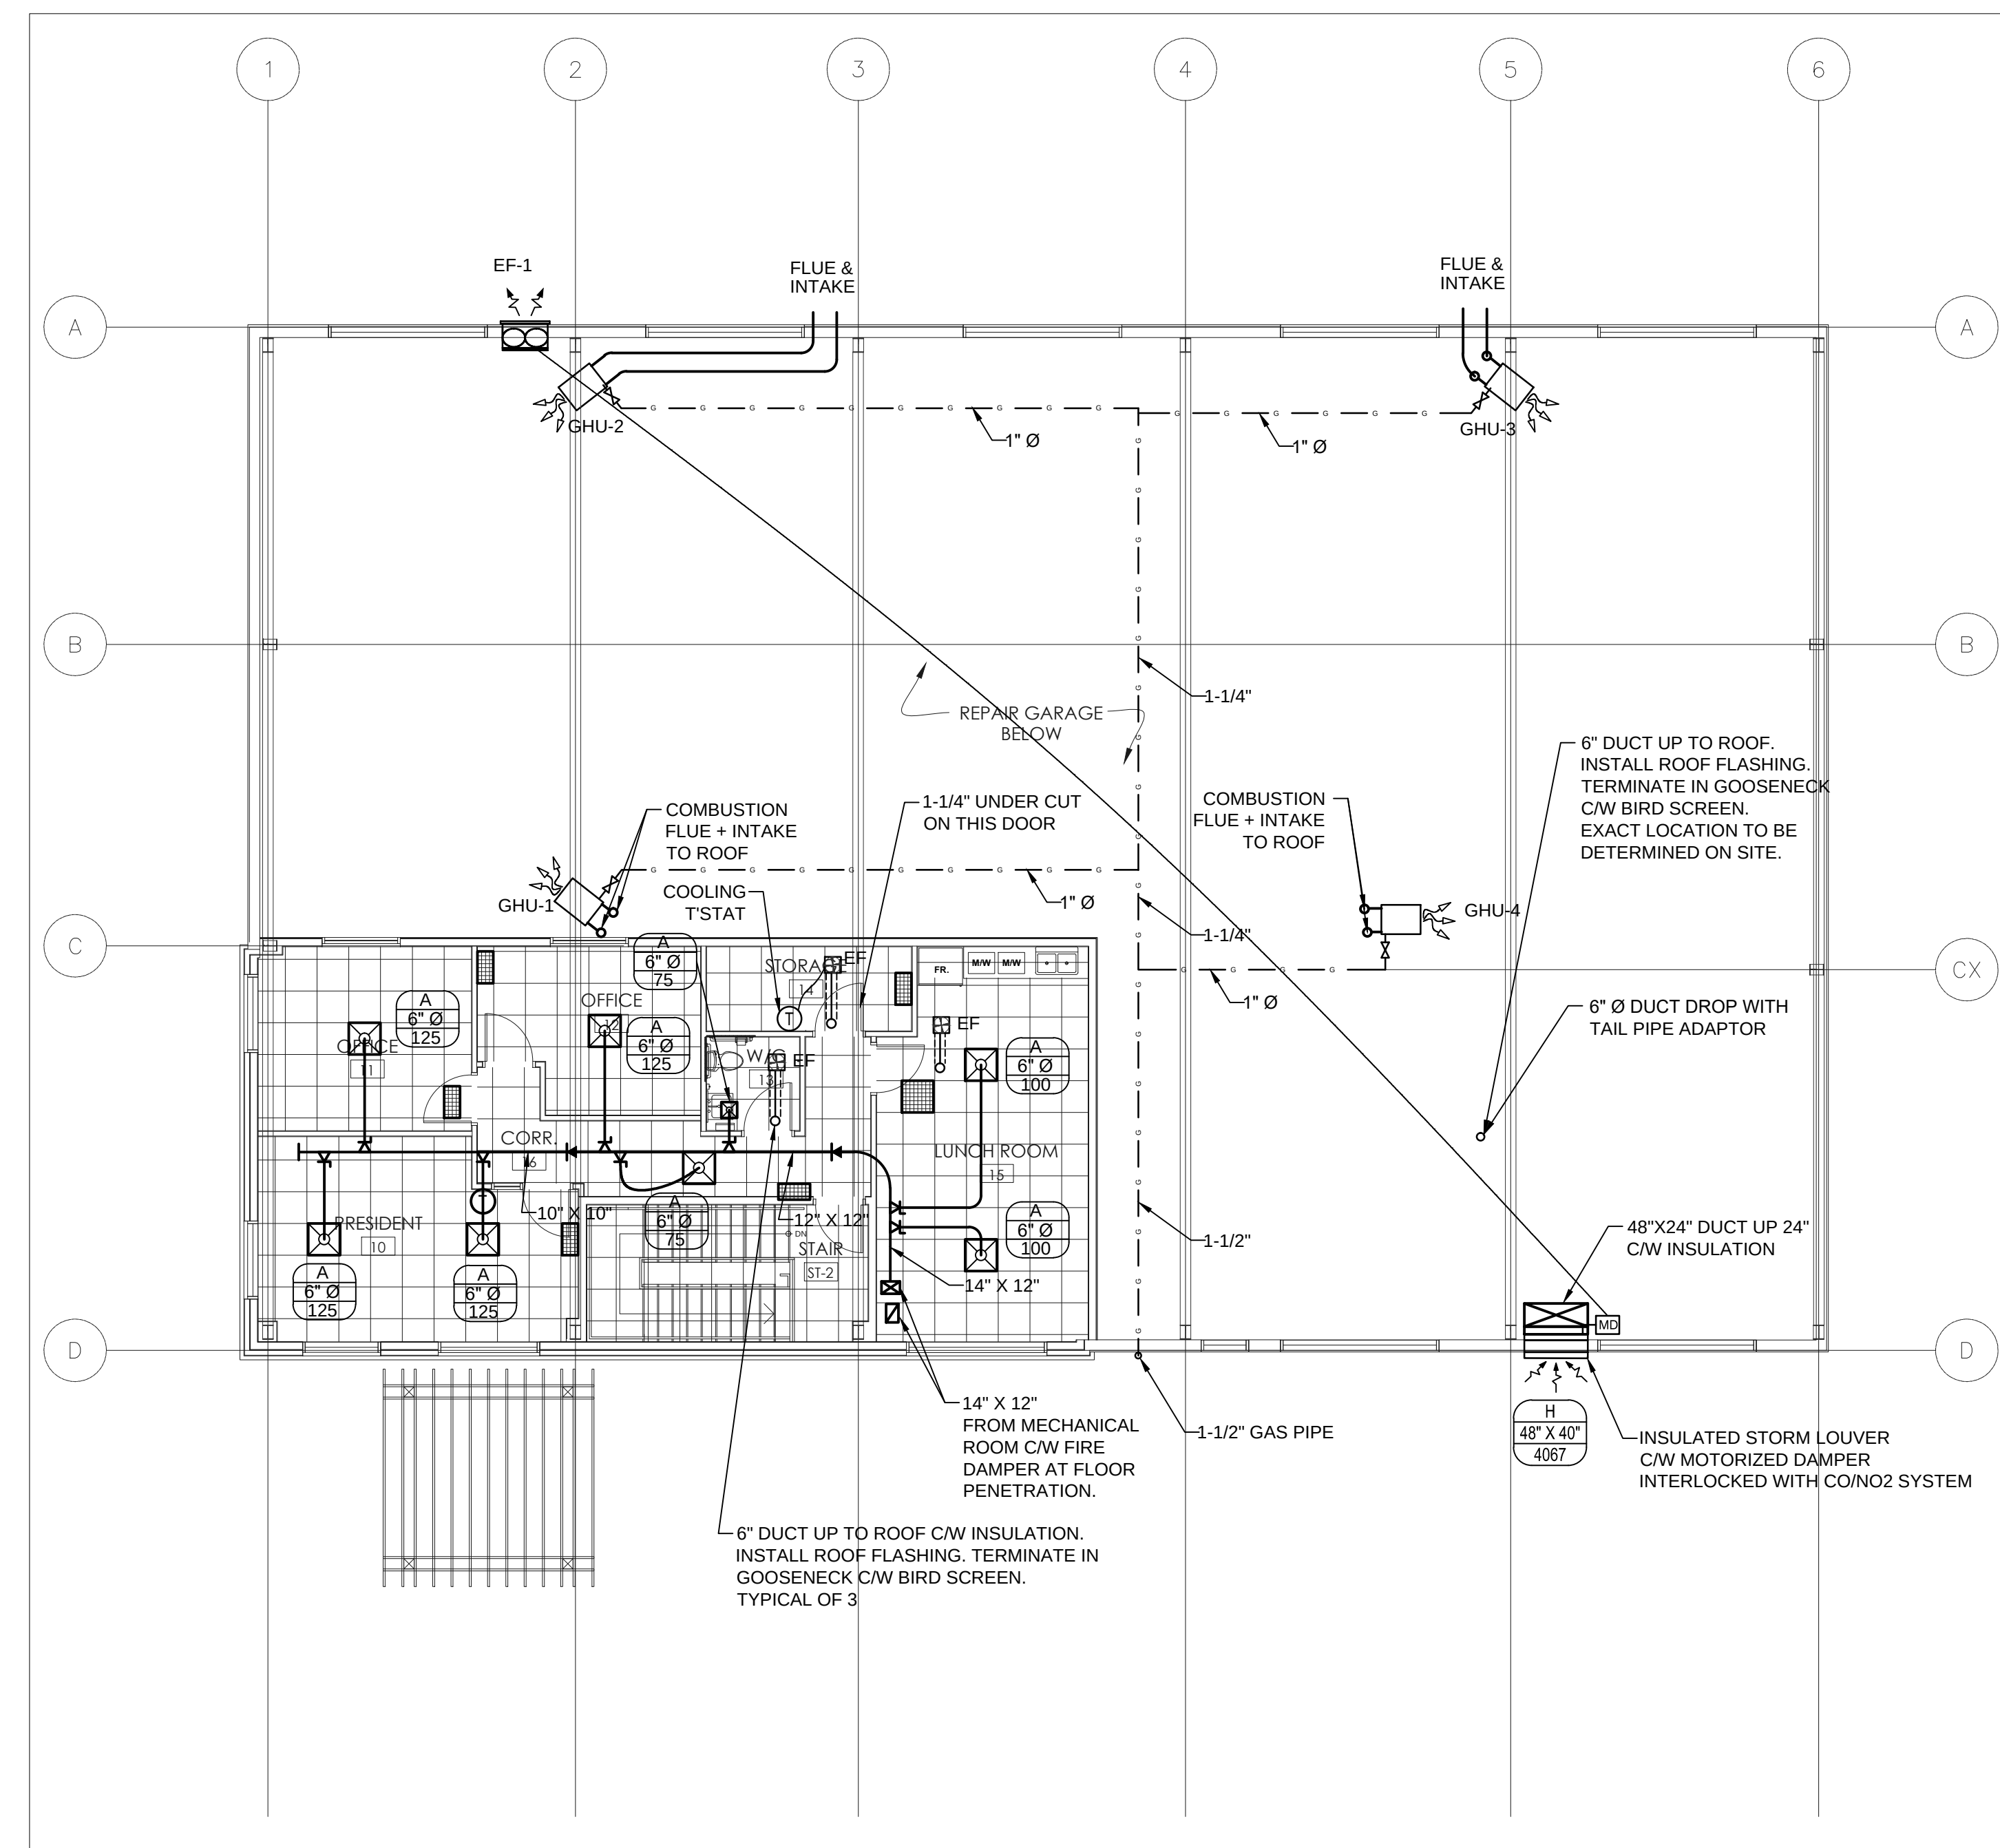


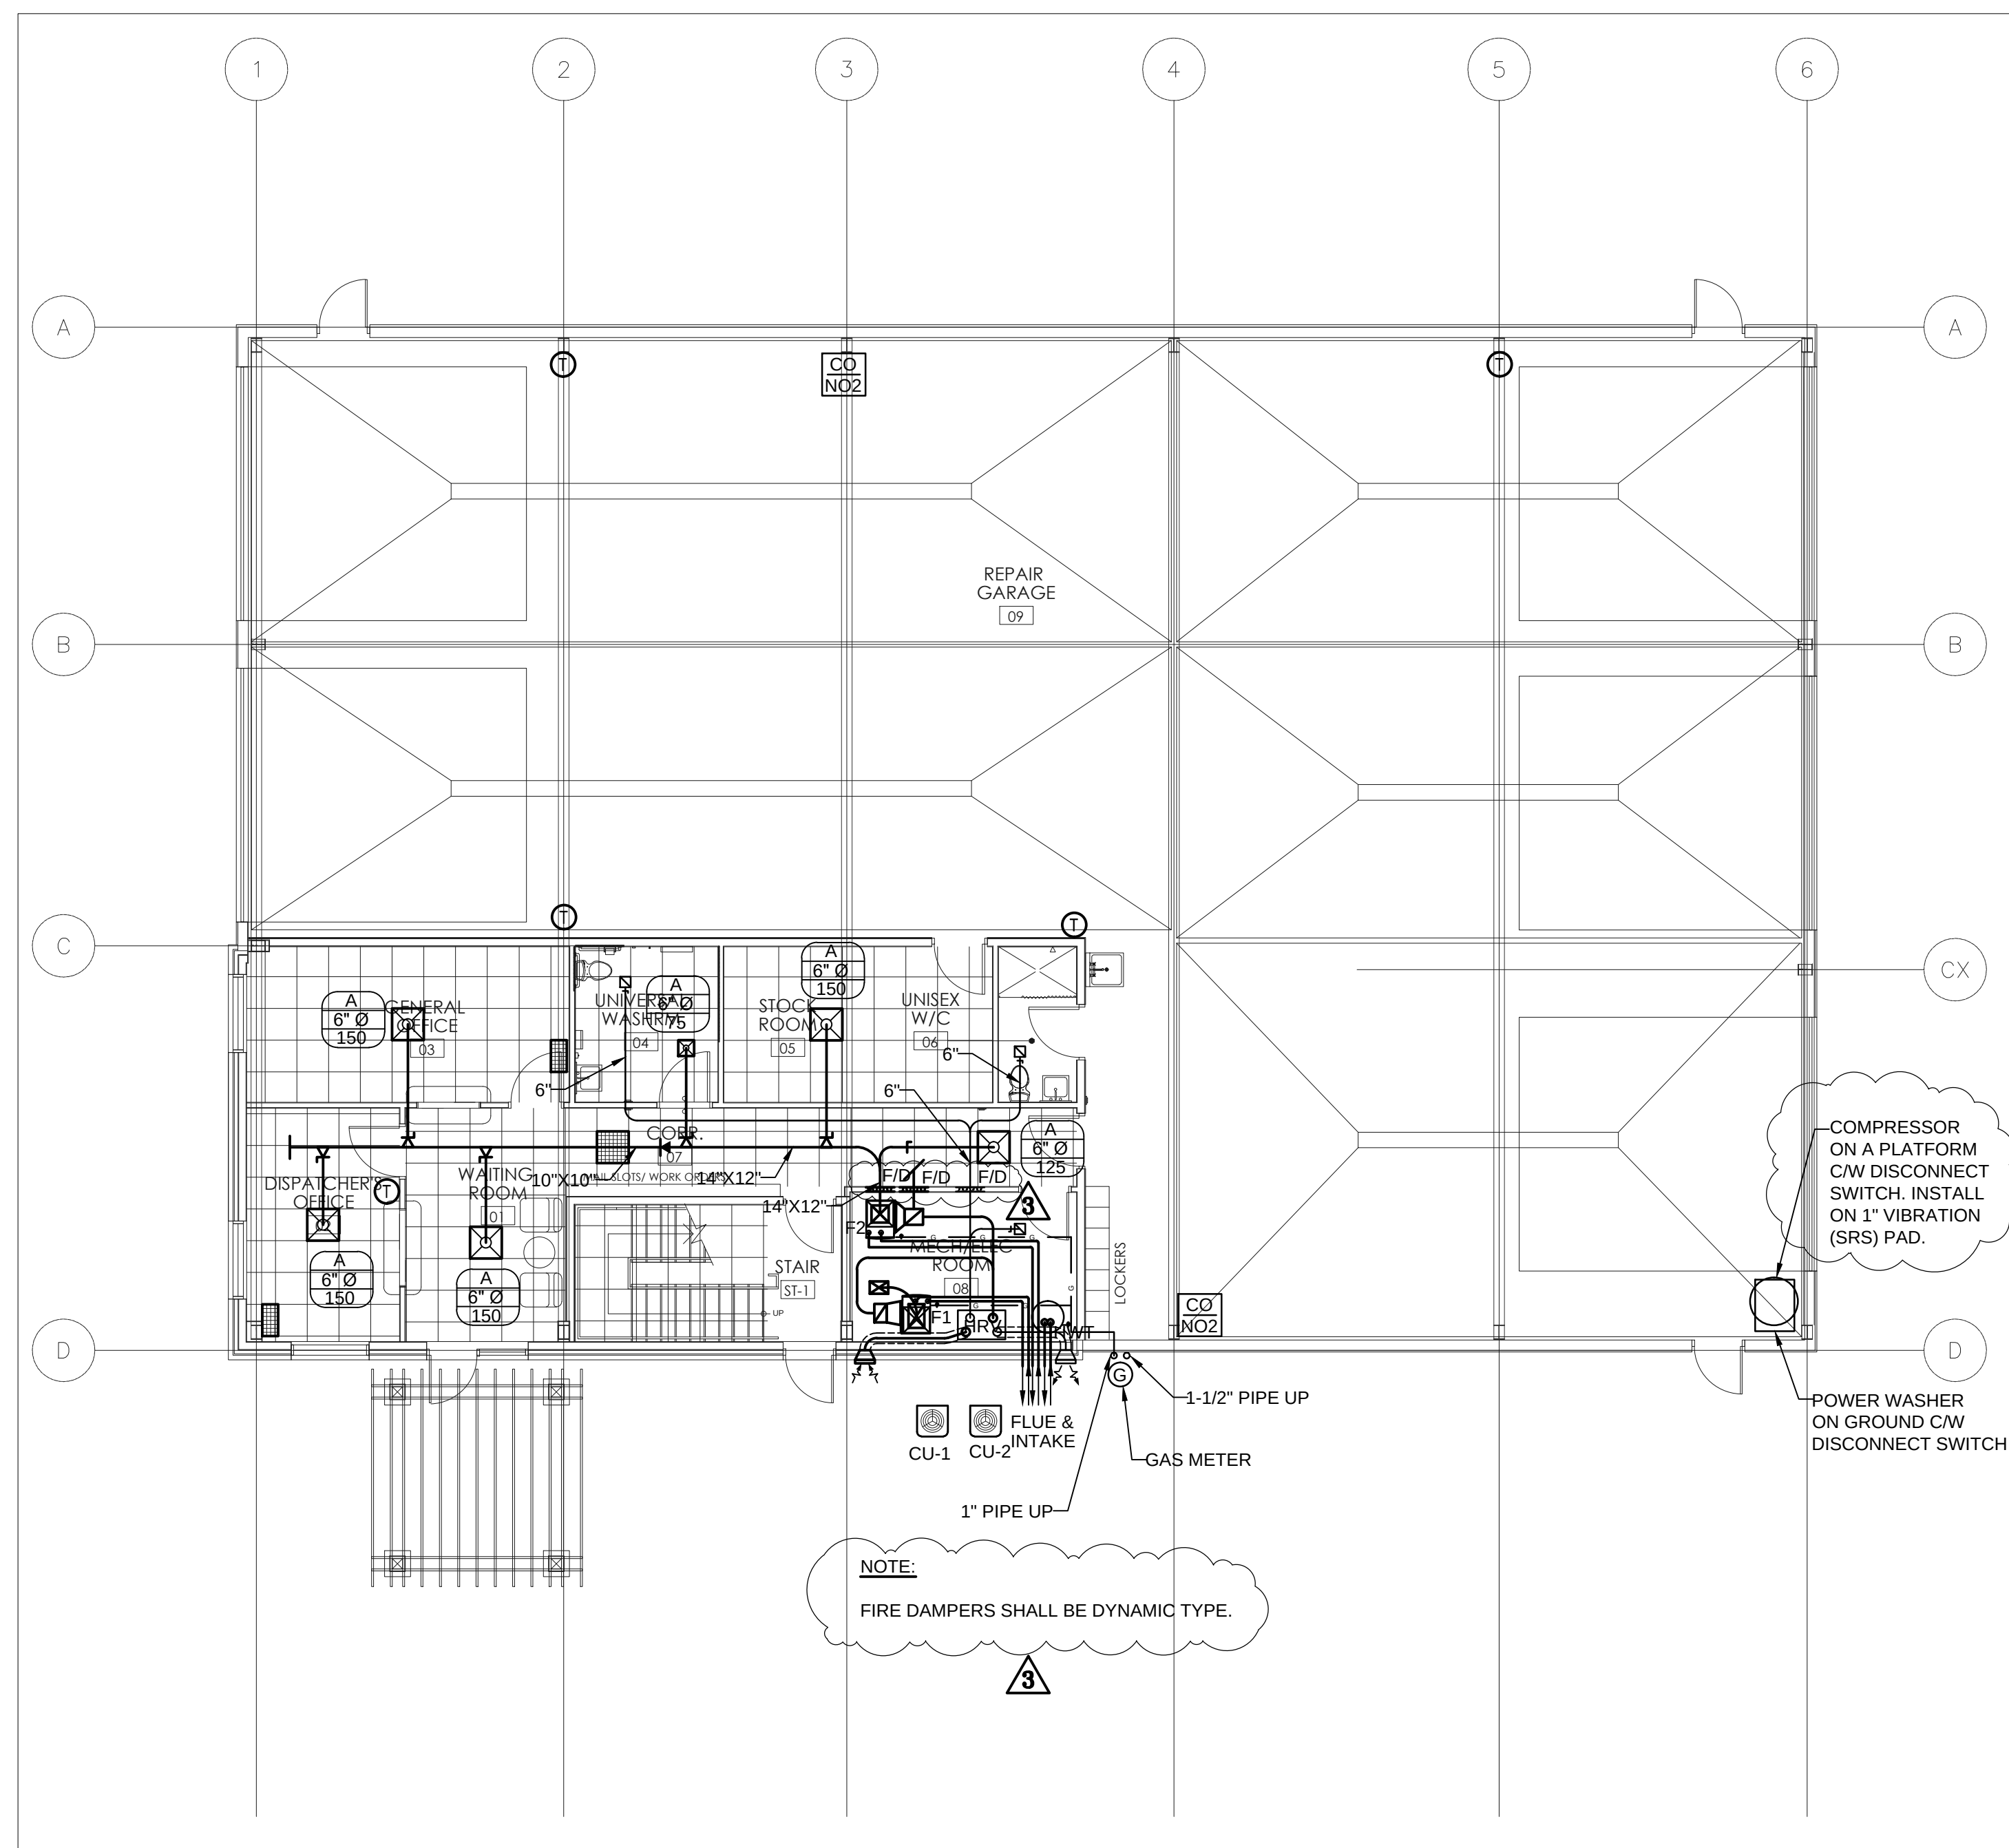


3	APR. 20, 2018	ADDED FIRE DAMPERS DELETED 4 TAIL PIPE DUCTS REVISED EF-1	MY
2	FEB. 28, 2018	PRICING	MY
1	JAN. 24, 2018	BUILDING PERMIT	MY
NO.	DATE	REVISION	NAME

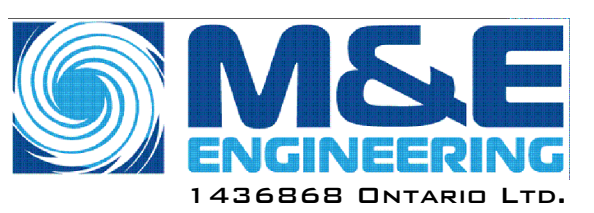

205 Kincardine Drive, Kanata, Ontario, K2V1C5
Tel: 613-836-3420 Fax: 613-836-5957

THIS DRAWING IS THE SOLE PROPERTY OF
M & E ENGINEERING. REPRODUCTION
IS NOT PERMITTED

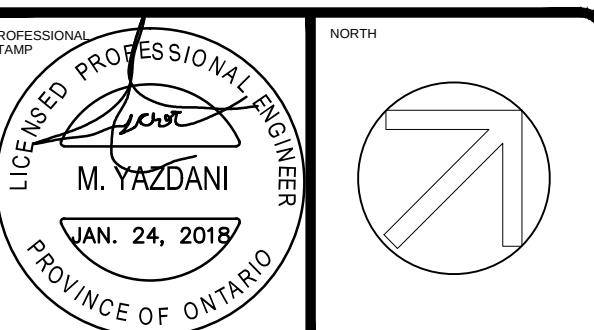

PROJECT

BRY-AIN HOLDINGS LTD.
EQUIPMENT REPAIR GARAGE

2688 CARP ROAD, OTTAWA, ON

GROUND & 2nd FLOOR HVAC LAYOUTS

PROJECT NUMBER	
CHECKED BY MY	DESIGNED BY MY
DRAWN BY SY	SCALE 1 : 100
DATE	DRAWING NUMBER M-3
REVISION	