


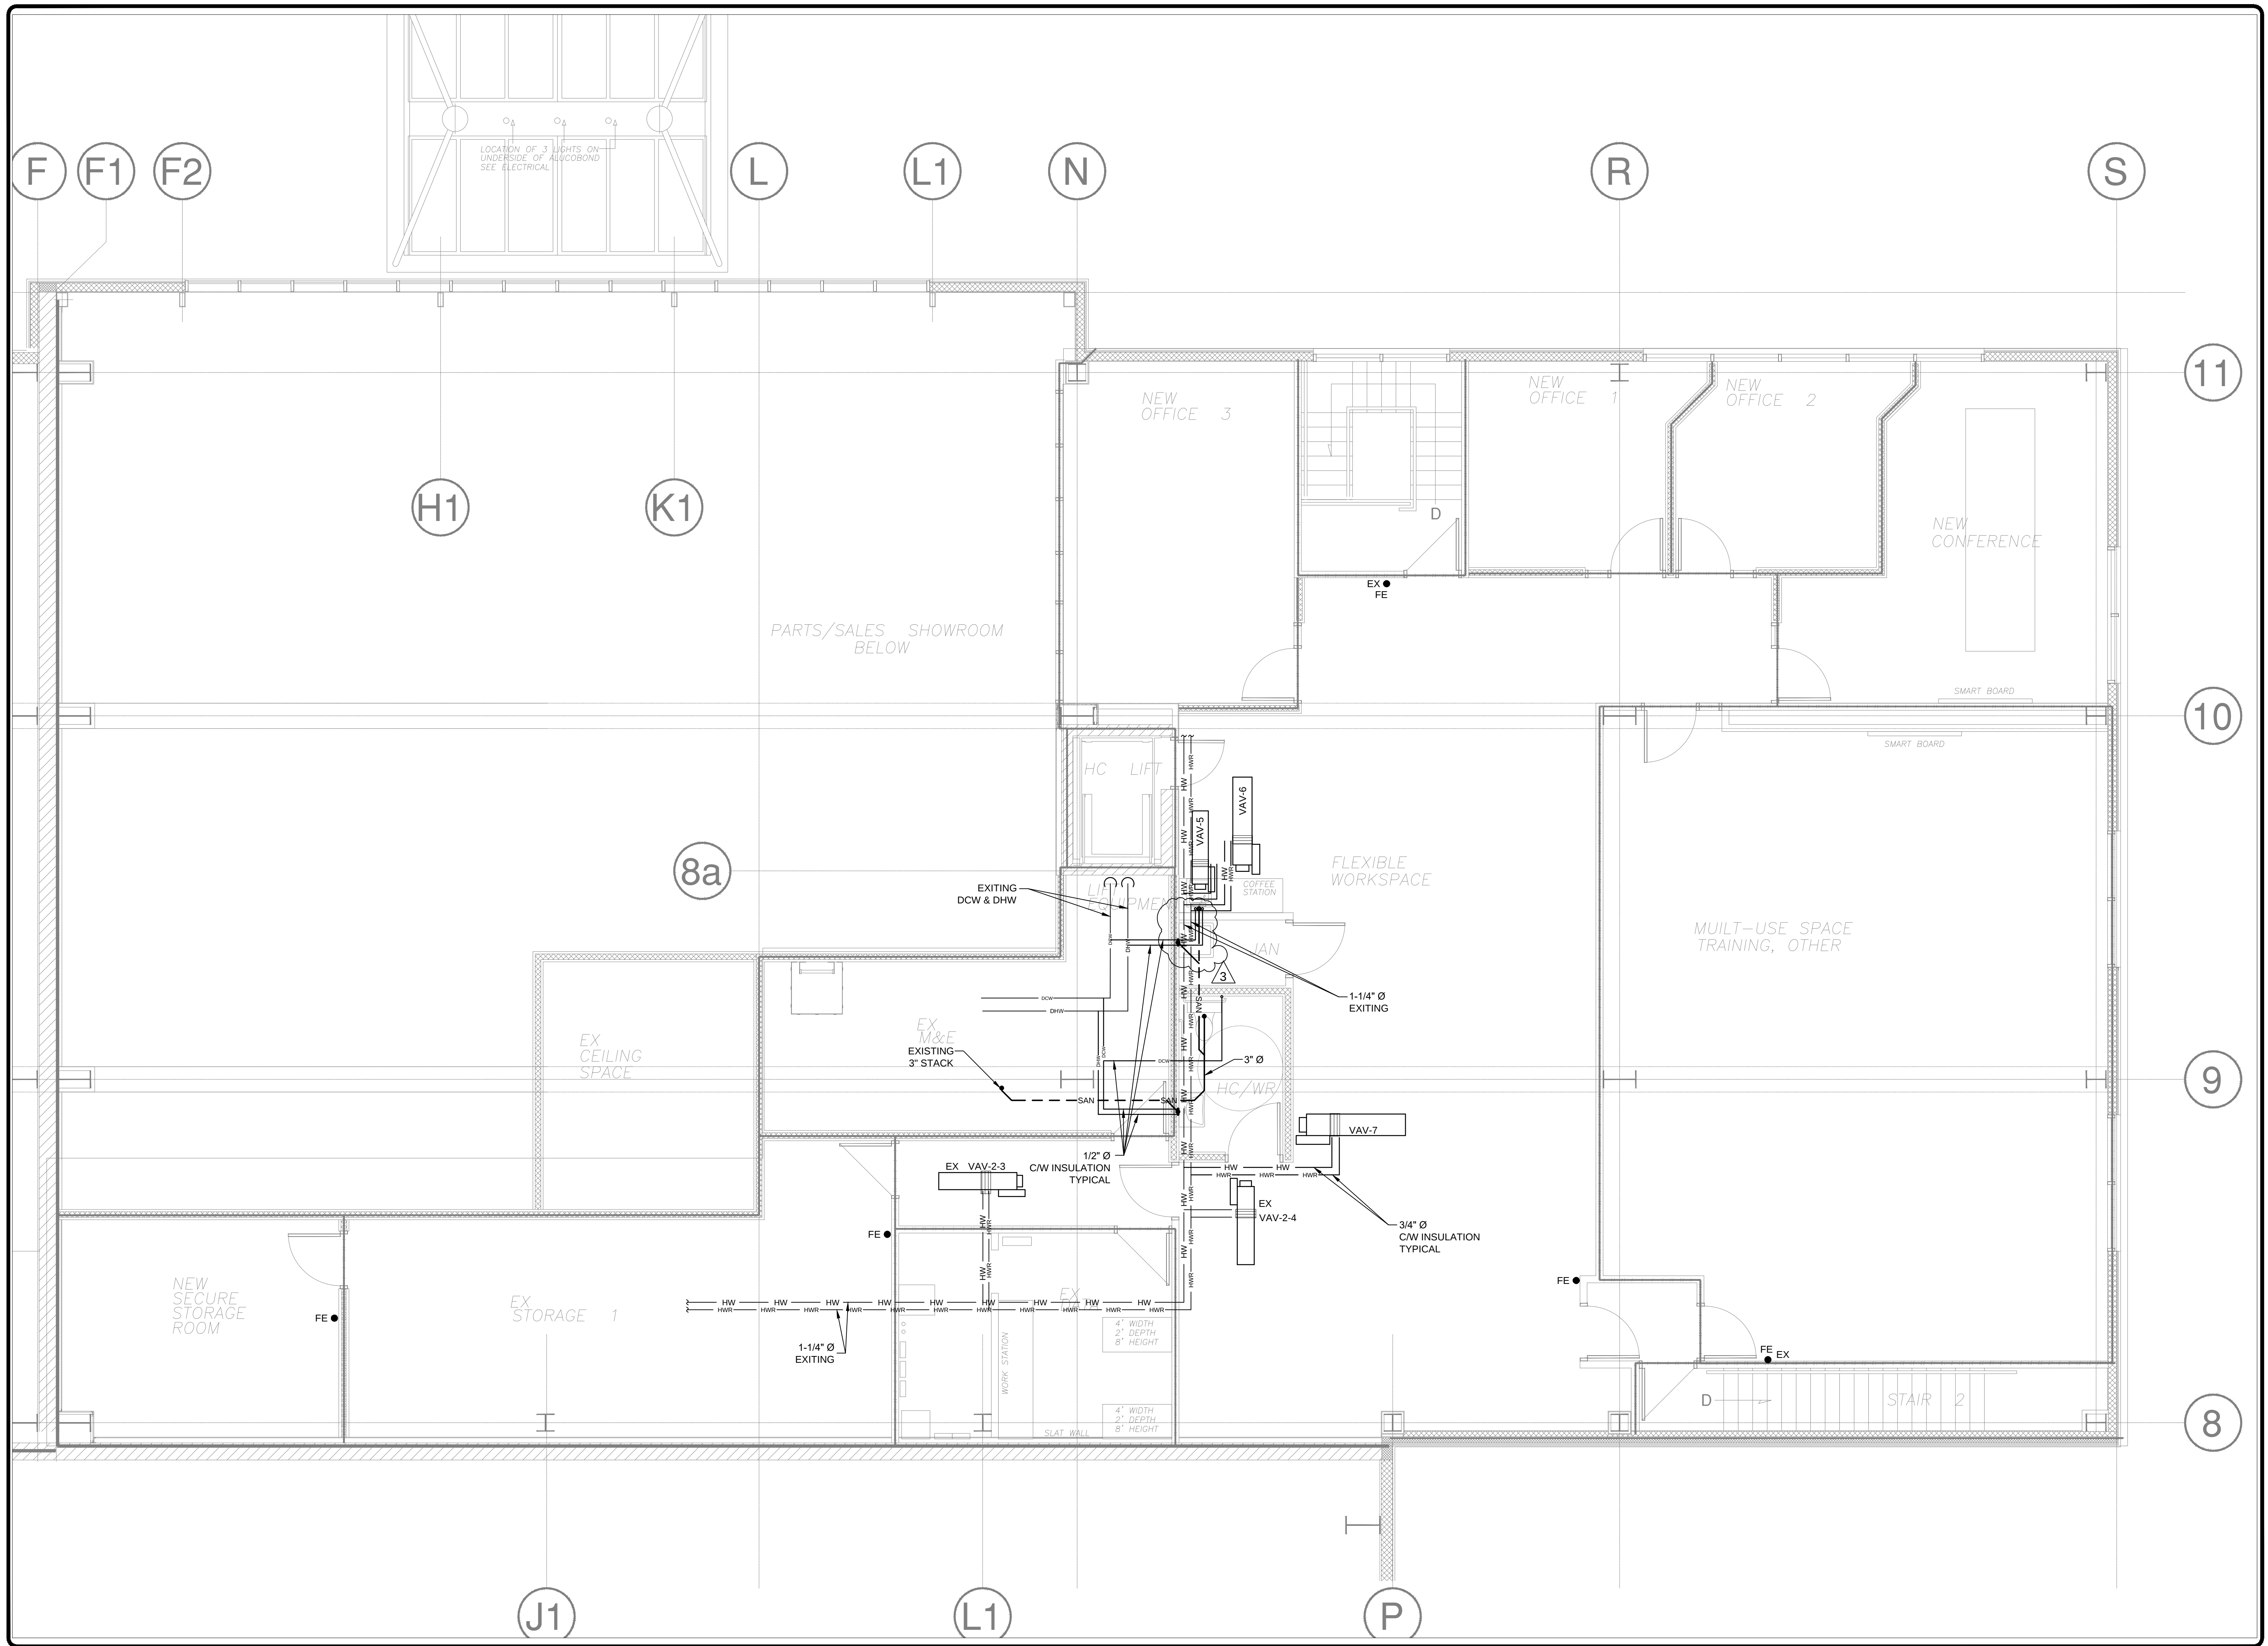

3	OCT. 10, 2018	ADDENDUM ME-1 & 2 REVISED DWGS M1, E1, & E3 ADDED PANEL SCHEDULE	MY
2	SEP. 20, 2018	PRICE	MY
1	SEPT. 7, 2018	BUILDING PERMIT	MY
NO.	DATE	REVISION	NAME

THIS DRAWING IS THE SOLE PROPERTY OF
M & E ENGINEERING. REPRODUCTION
IS NOT PERMITTED



PROJECT
NORTRAX OTTAWA
UPPER LEVEL FIT-UP
190 DAVID MANCHESTER RD., OTTAWA, ON

DRAWING
SECOND FLOOR
PLUMBING LAYOUT

PROJECT NUMBER	
CHECKED BY MY	DESIGNED BY MY
DRAWN BY SY	SCALE 1 : 50
DATE	DRAWING NUMBER
REVISION	M-1