


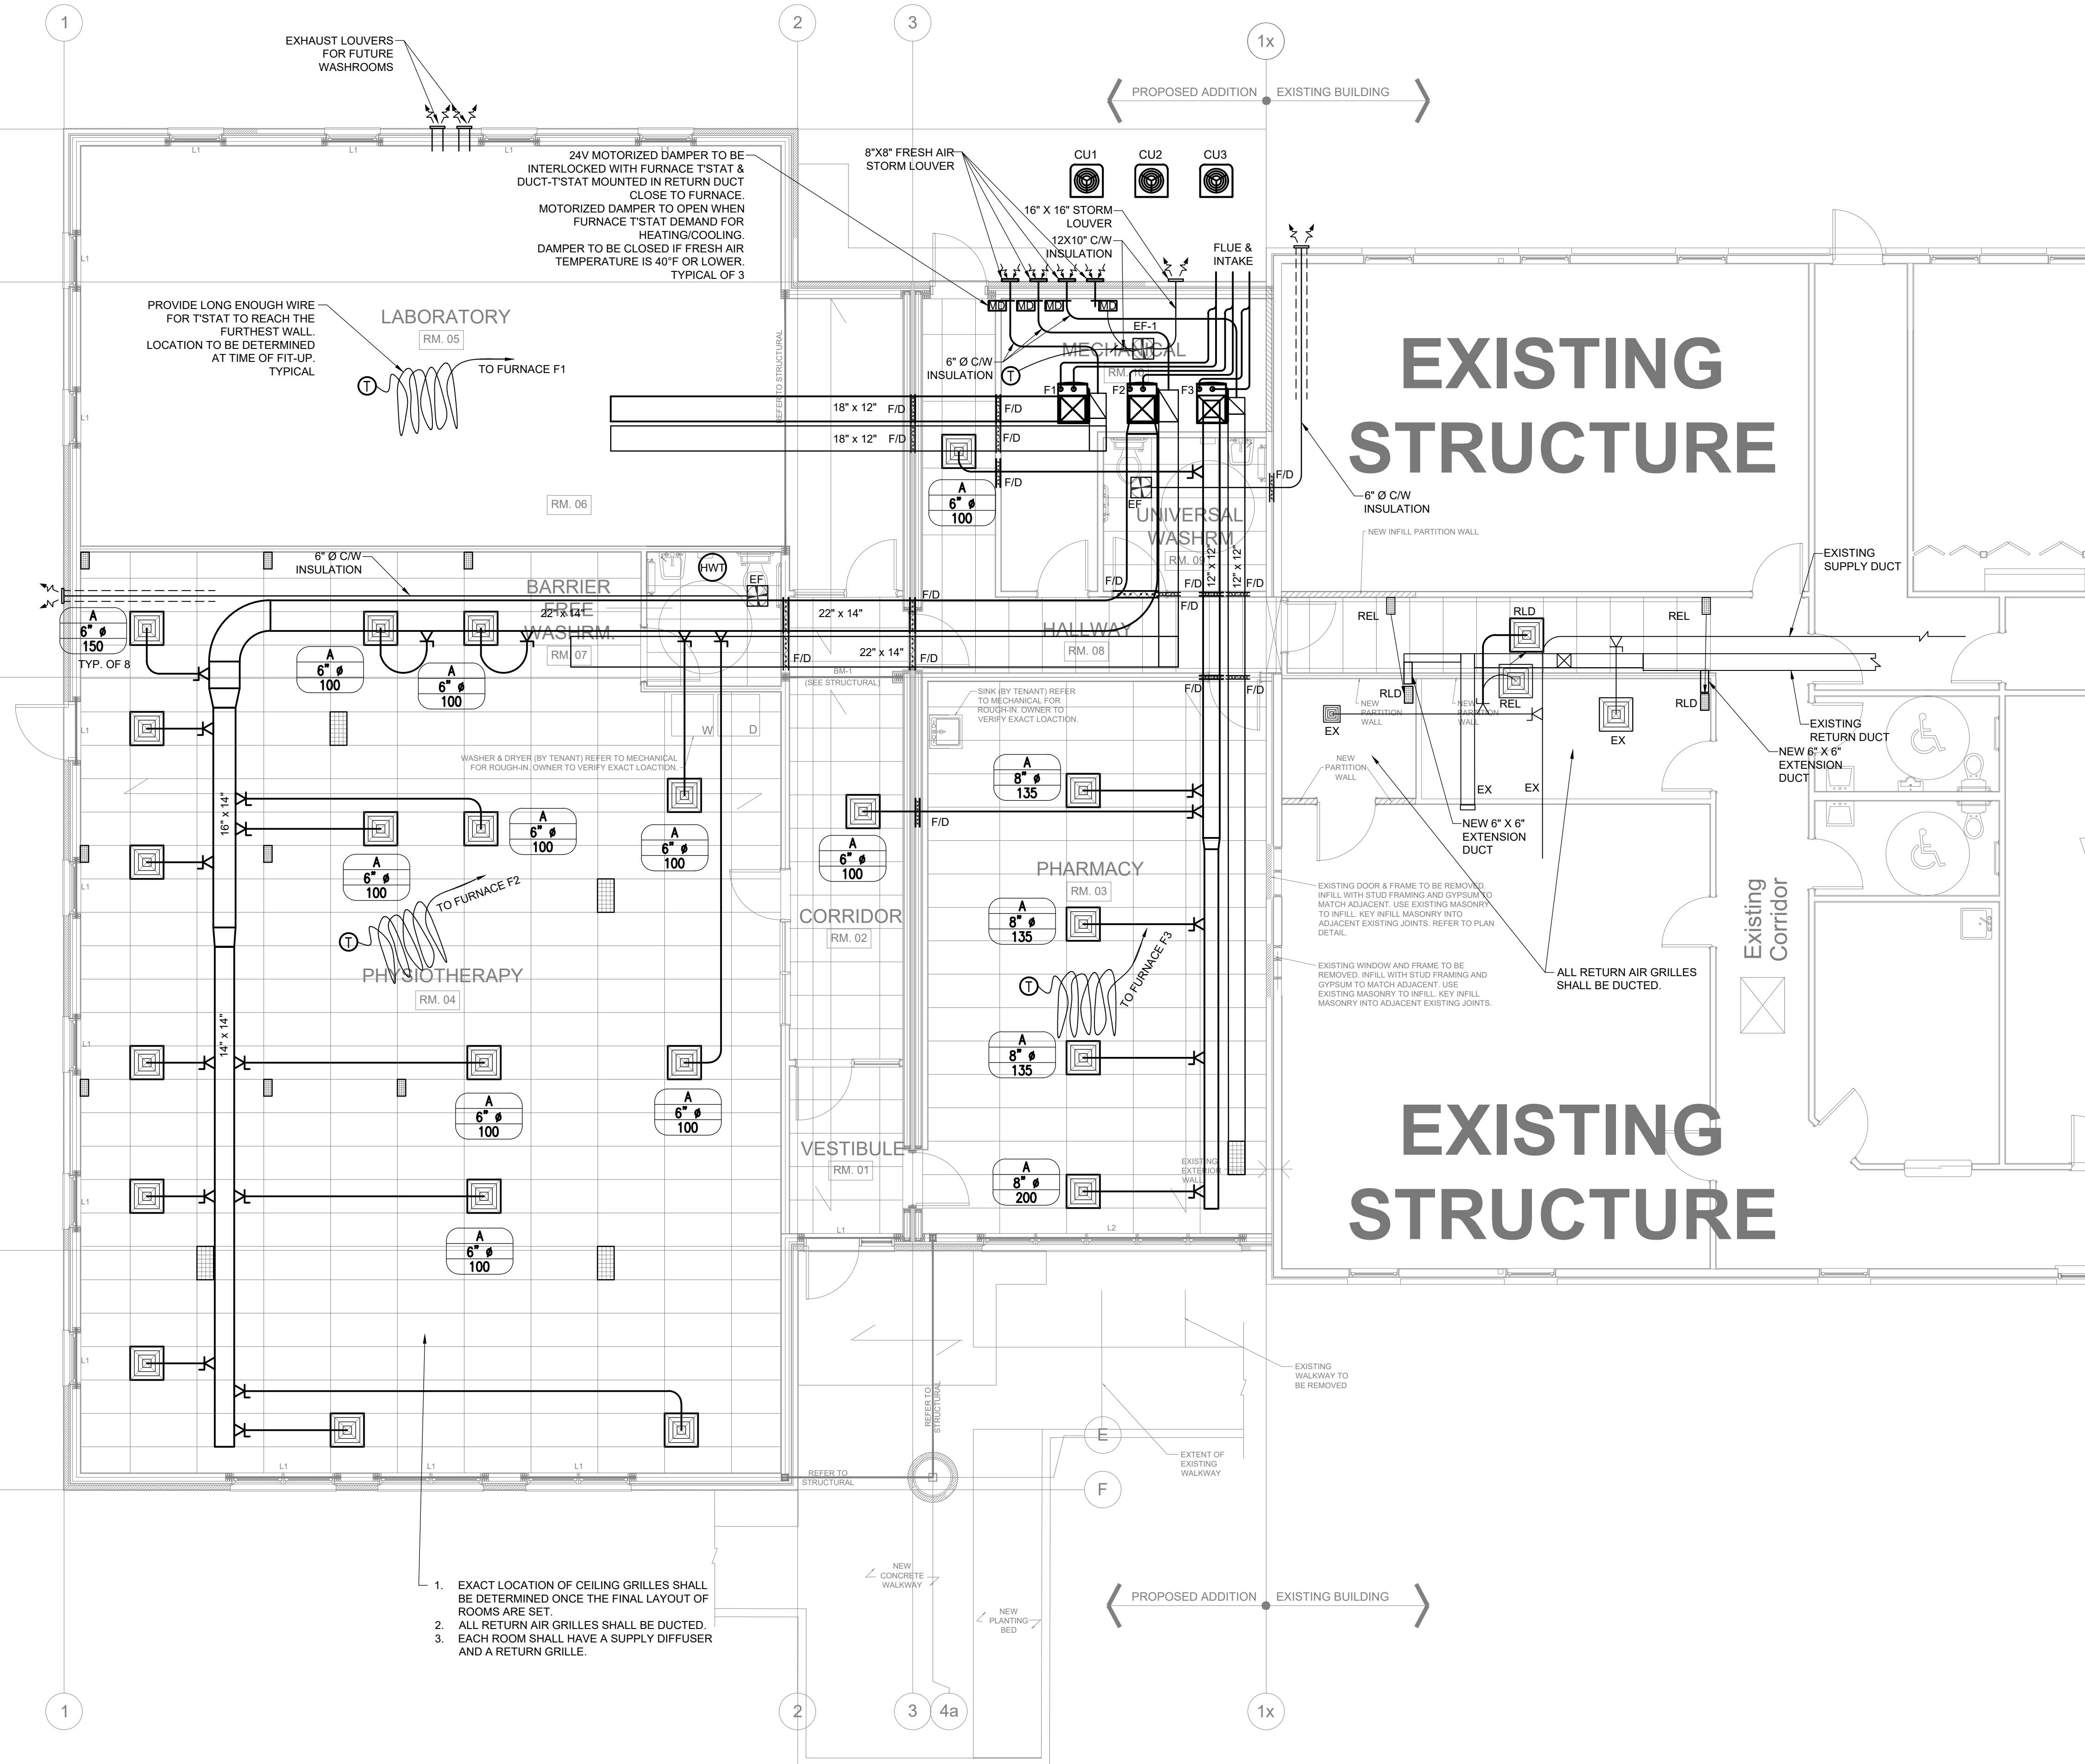

NO.	DATE	REVISION	NAME
2	OCT. 15, 2018	PRICING	MY
1	SEPT. 26, 2018	BUILDING PERMIT	MY

305 Kincardine Drive, Kanata, Ontario, K2Y1G5
Tel: 613-856-5420 Fax: 613-856-5957

THIS DRAWING IS THE SOLE PROPERTY OF
M & E ENGINEERING. REPRODUCTION
IS NOT PERMITTED



PROJECT
PETAWAWA CENTENNIAL
FAMILY HEALTH CENTRE
154 CIVIC CENTRE RD., PETAWAWA, ON

DRAWING
HVAC LAYOUT

PROJCT NUMBER	
CHECKED BY	MY
DESIGNED BY	MY
DRAWN BY	FH
DATE	
REVISION	
SCALE	3/16" = 1'-0"
DRAWING NUMBER	M-2